

MOGAVERO
PERKINS
EASTON

ARCHITECTS

811 J STREET
SACRAMENTO, CA. 95814
(916) 443-1033

CONSULTANTS

PROJECT

childCARE

A Facility of
Eskaton Health
Corporation

marshall school
2716 g street
sacramento, ca.
95816

REVISIONS

DRAWING
POWER AND
SIGNAL PLAN

DRAWN BY

JB

PROJECT NUMBER

8326


DATE

6-15-84

SHEET NUMBER

E2

OF 12

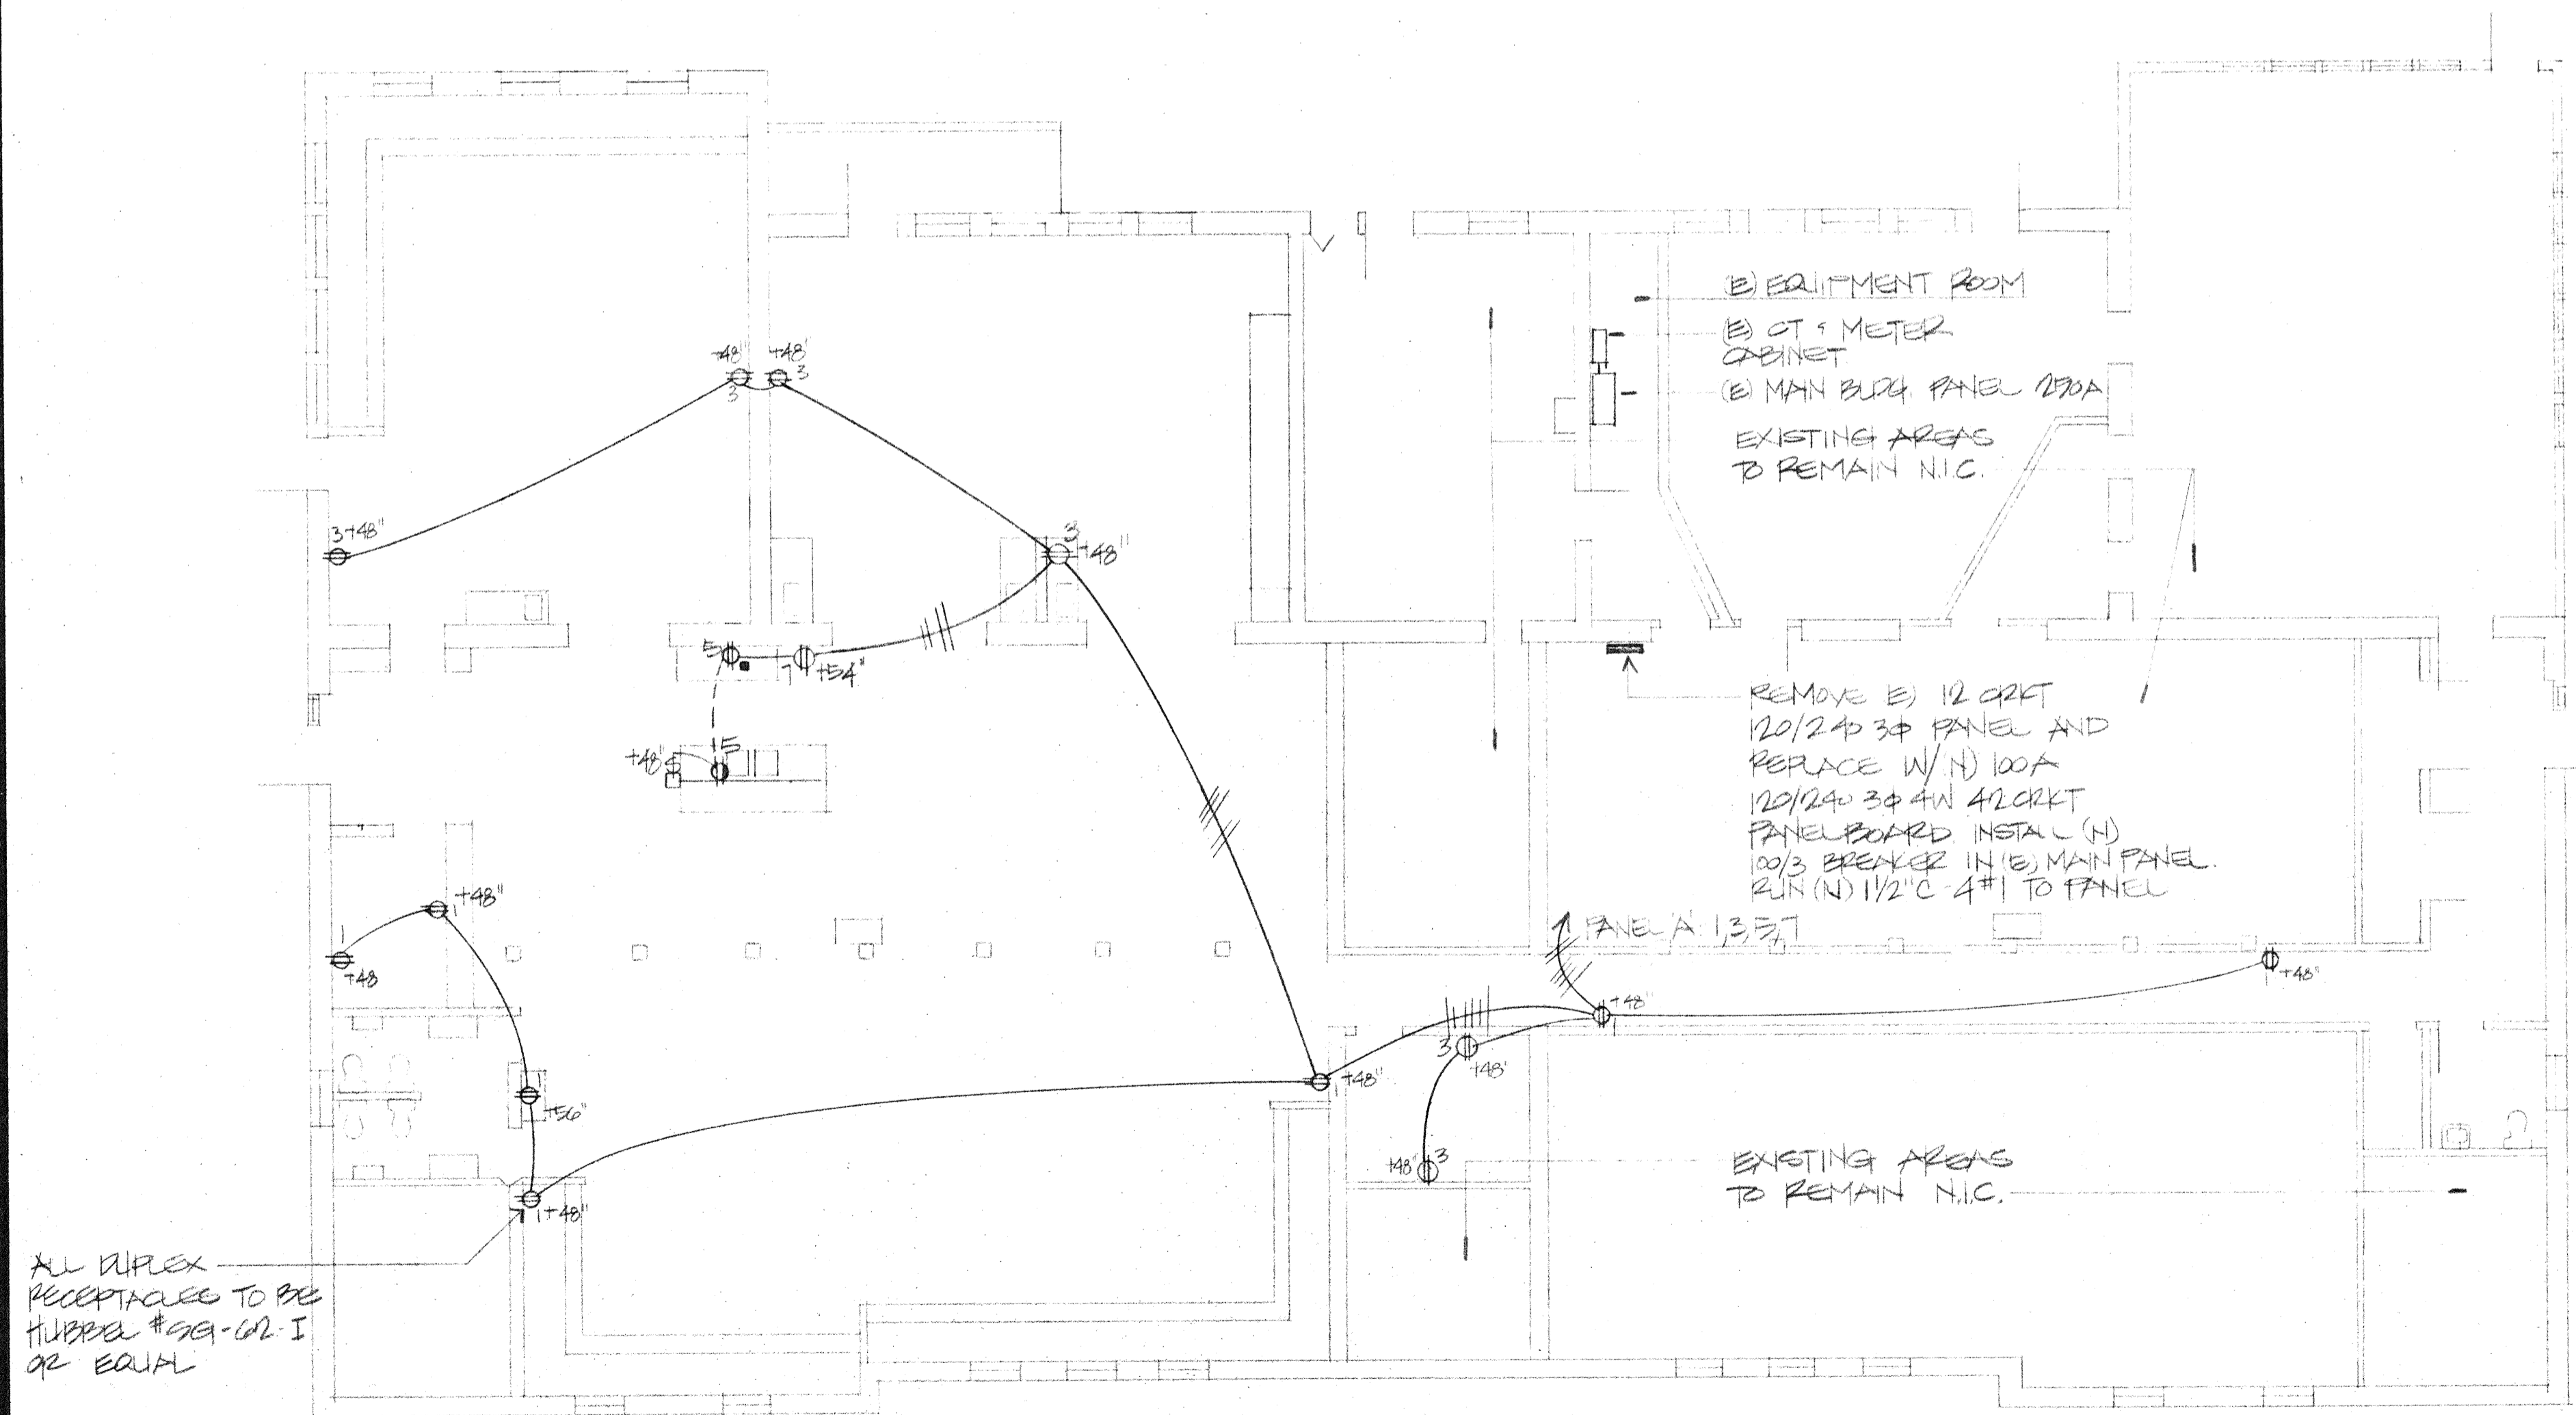

FLOOR PLAN - POWER AND SIGNAL
SCALE: 1/8" = 1'-0"

